


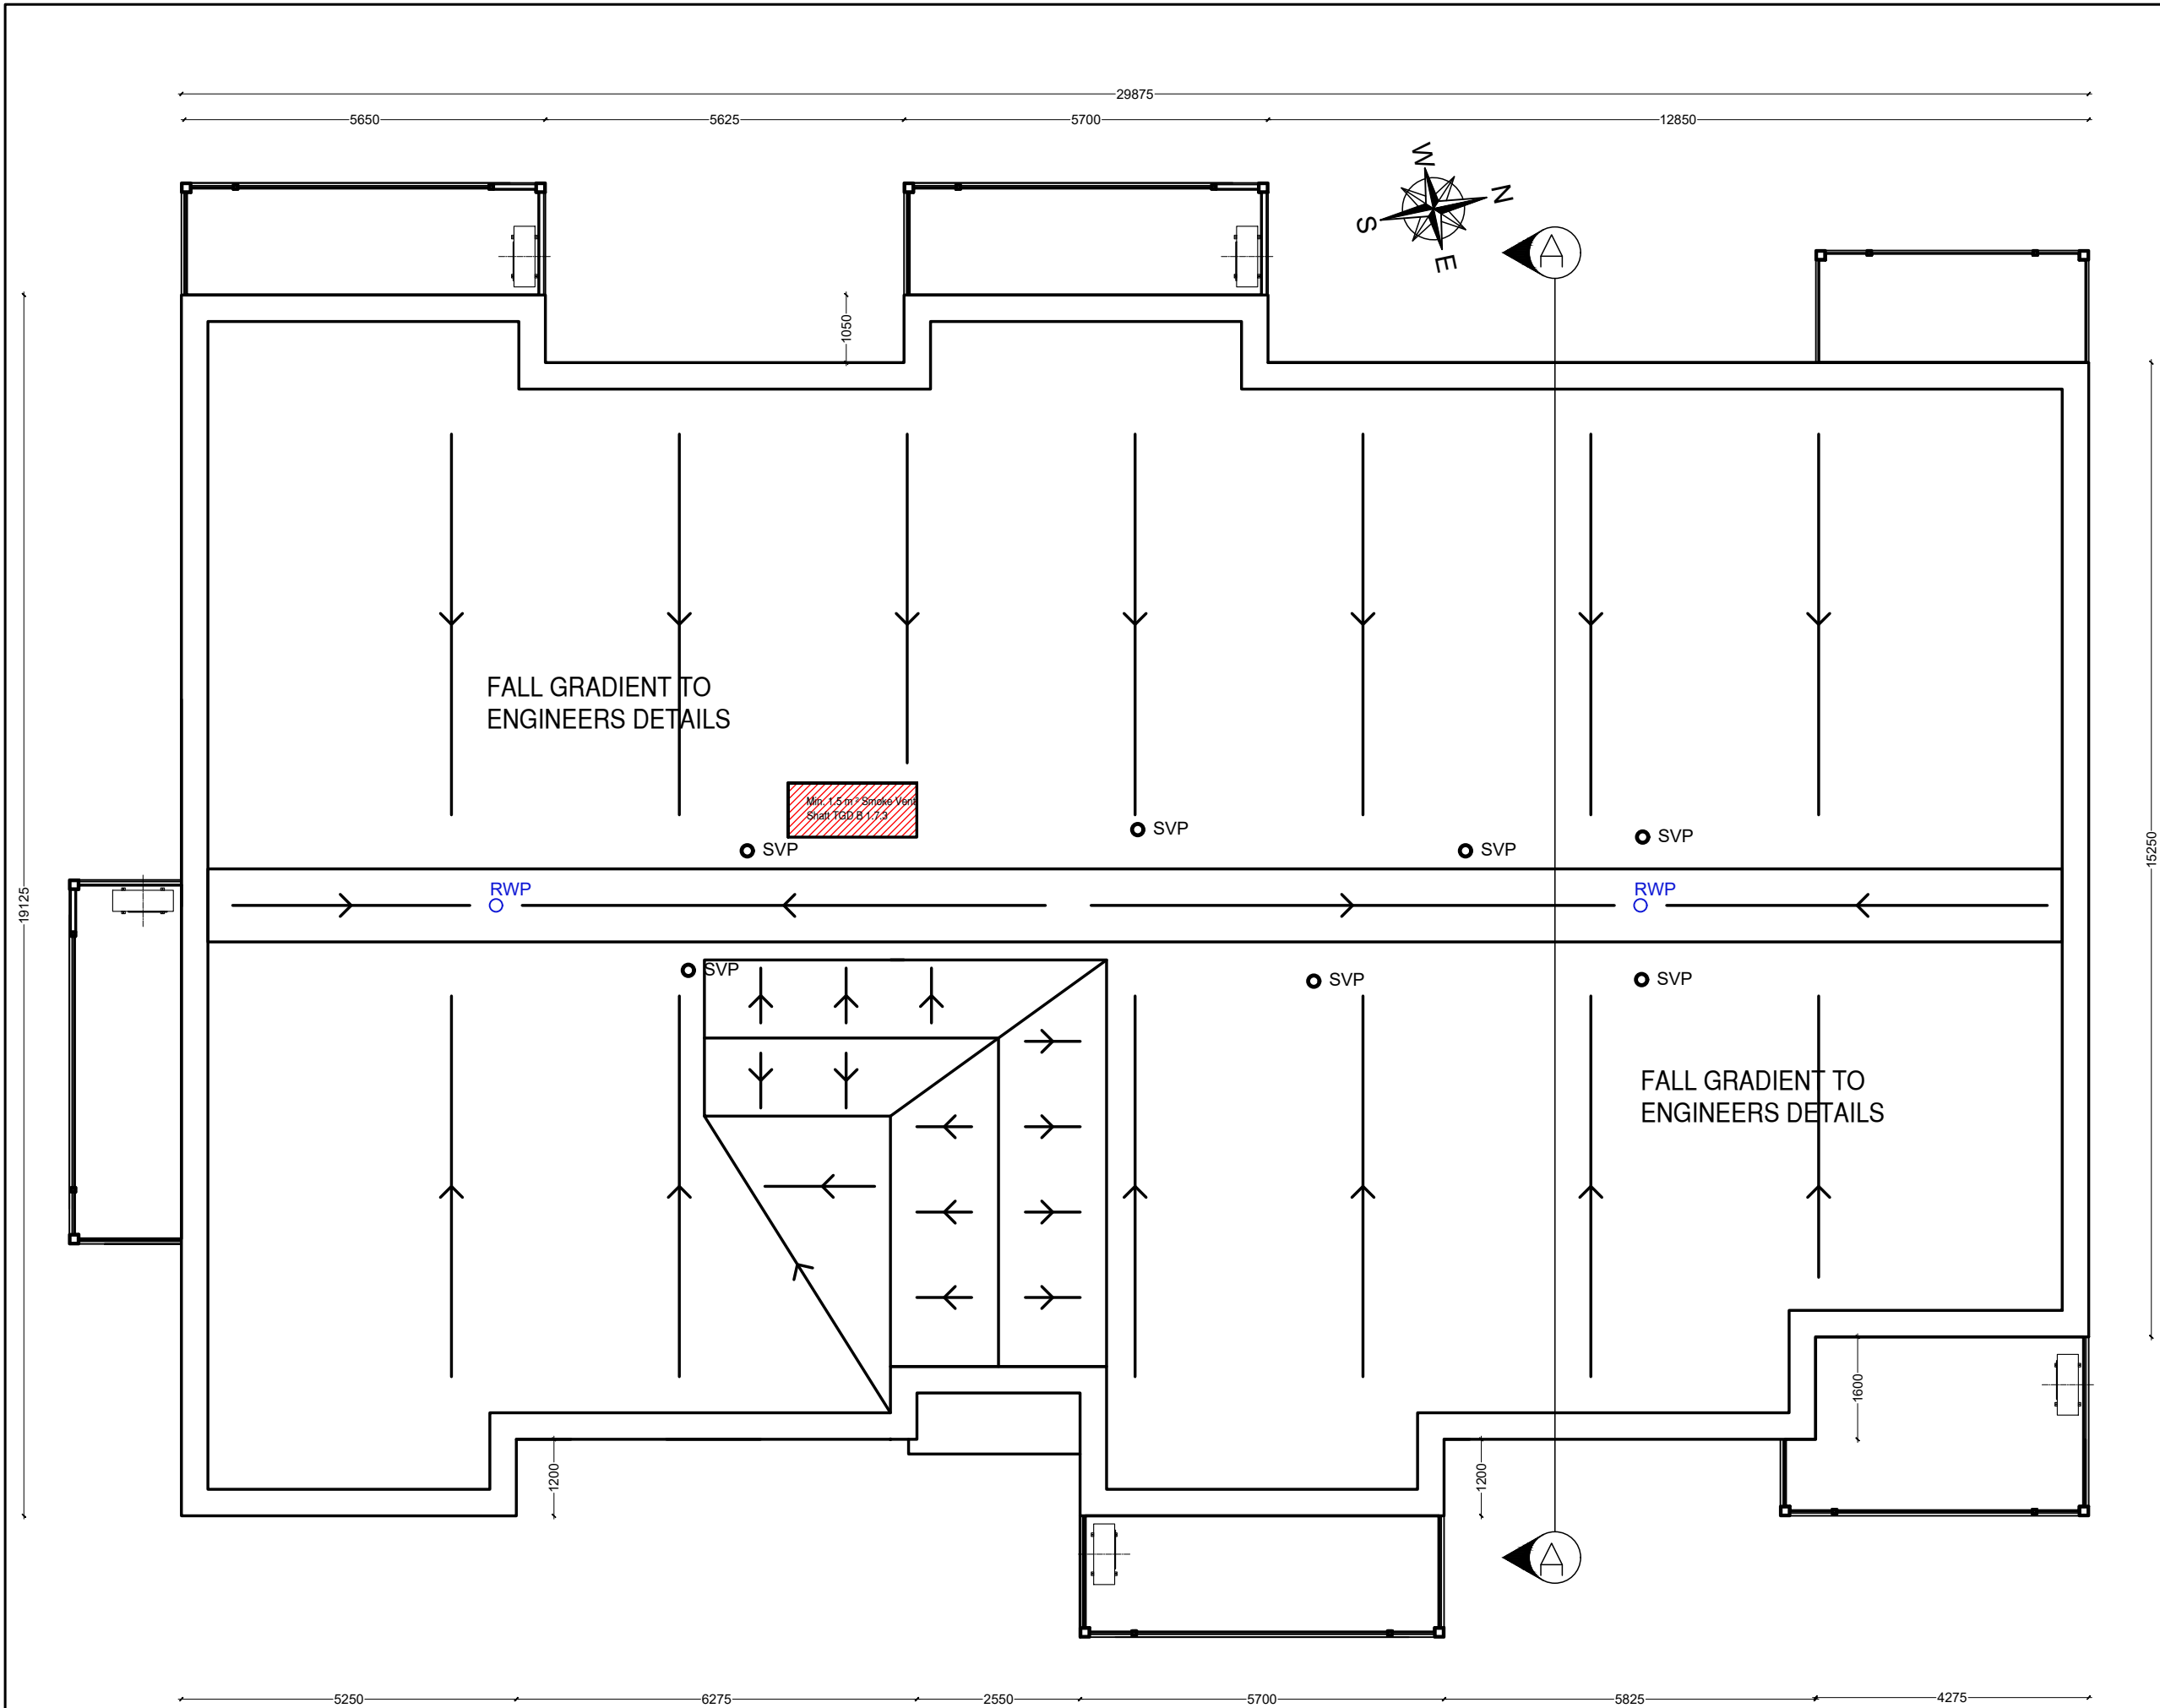



DO NOT SCALE FROM THIS DRAWING. USE FIGURED DIMENSIONS IN ALL CASES.
 VERIFY DIMENSIONS ON SITE AND REPORT ANY DISCREPANCIES TO THE ARCHITECTS IMMEDIATELY.
 THIS DRAWING IS TO BE READ IN CONJUNCTION WITH THE ARCHITECTS SPECIFICATION.
 THIS DRAWING IS COPYRIGHT AND MAY ONLY BE REPRODUCED WITH THE ARCHITECTS PERMISSION.

NOTES



LEGEND:

-  **Soil Vent Pipe**
-  **Rainwater Downpipe**
-  **Drainage Direction**
-  **Smoke Vent AOV**

| REV | DATE | DRN | NOTES |
|-----|------|-----|-------|
| | | | |
| | | | |
PLANNING

Gittens Murray Architects Ltd.

JOB
 WATERROCK HOUSING
 MIDLETON, CO.CORK

CLIENT
 HAVEN FALLS LTD.

TITLE
 APARTMENT TYPE 'A'
 BLOCK No.'s 1,2 & 4
 PROPOSED ROOF PLAN

DATE 07.10.2022 SCALE 1:100 @A3
 DRN SH CHECKED MG

GMA
 ARCHITECTS
 INTERIOR DESIGNERS

2 Patricks Court,
 Patricks St.
 Kilkenny.

JOB NUMBER 20/033-LRD-A-A-104
 DRWG NUMBER REVISION

T E L: (0 5 6) 77 53933
 F A X: (0 5 6) 77 53909
 email: info@gmarch.net

DETAIL NUMBER
 LOCATION SHEET
 DETAIL SCALE